


KEY:

- ⊕ SWITCH
- ⊕ DUPLEX OUTLET
- ⊕ FLOOR OUTLET
- ⊕ COUNTER HEIGHT
- ▽ TELEPHONE/ETHERNET
- ⊕ THERMOSTAT
- ▣ EXHAUST FAN

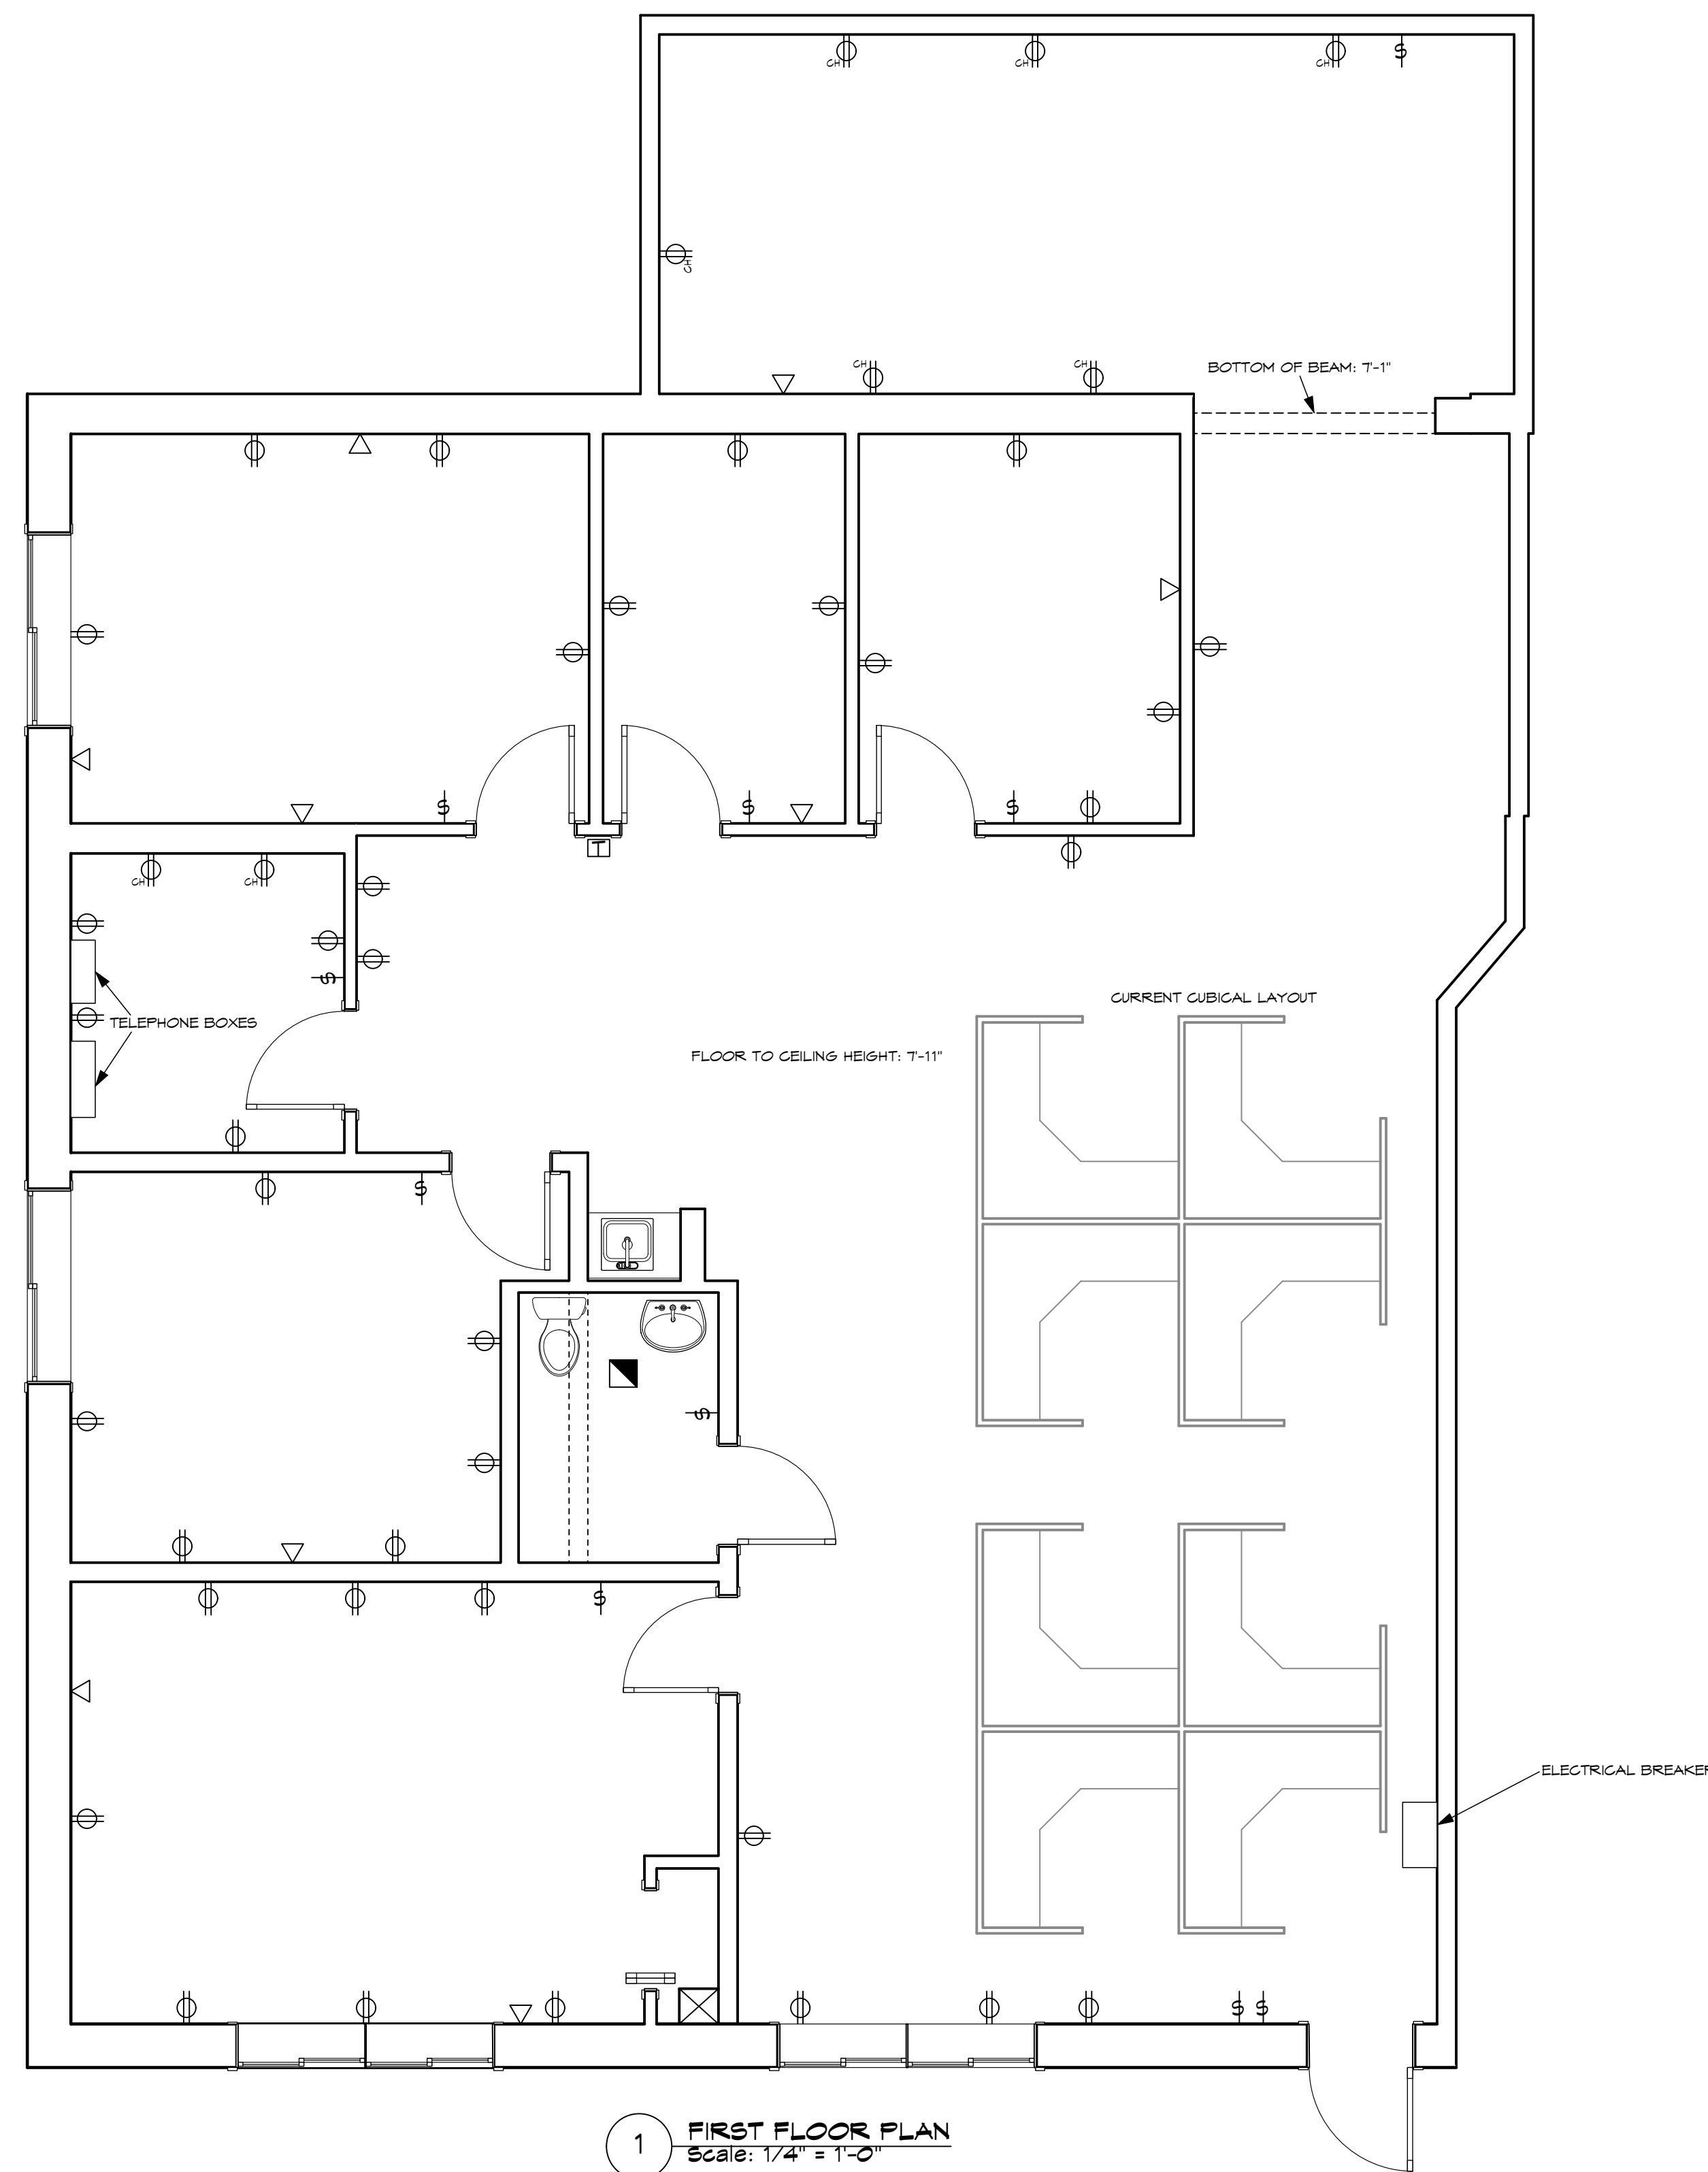

1 **FIRST FLOOR PLAN**
Scale: 1/4" = 1'-0"

DATE:

REV.:

SCALE:

1/4"=1'-0"

DRAWN BY:

CFB

O'BRIEN BROTHERS AGENCY

**UNIT B, 88 LEROY RD.
WILLISTON, VT 05495**

O'BRIEN
BROTHERS
AGENCY INC

1888 WILLISTON ROAD
SOUTH WILLISTON, VT 05403
802-895-0000
www.obrienbrothersagency.com

FLOOR PLAN

A-1

88 LEROY ROAD

© O'BRIEN BROTHERS AGENCY, INC.